



Plan View
Scale - 1 : 250

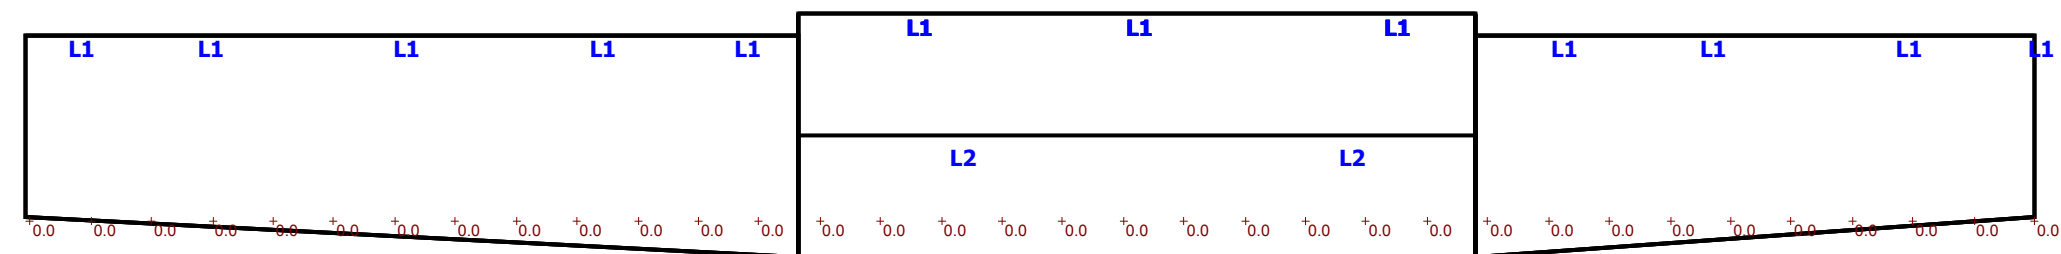

South View
Scale - 1 : 250

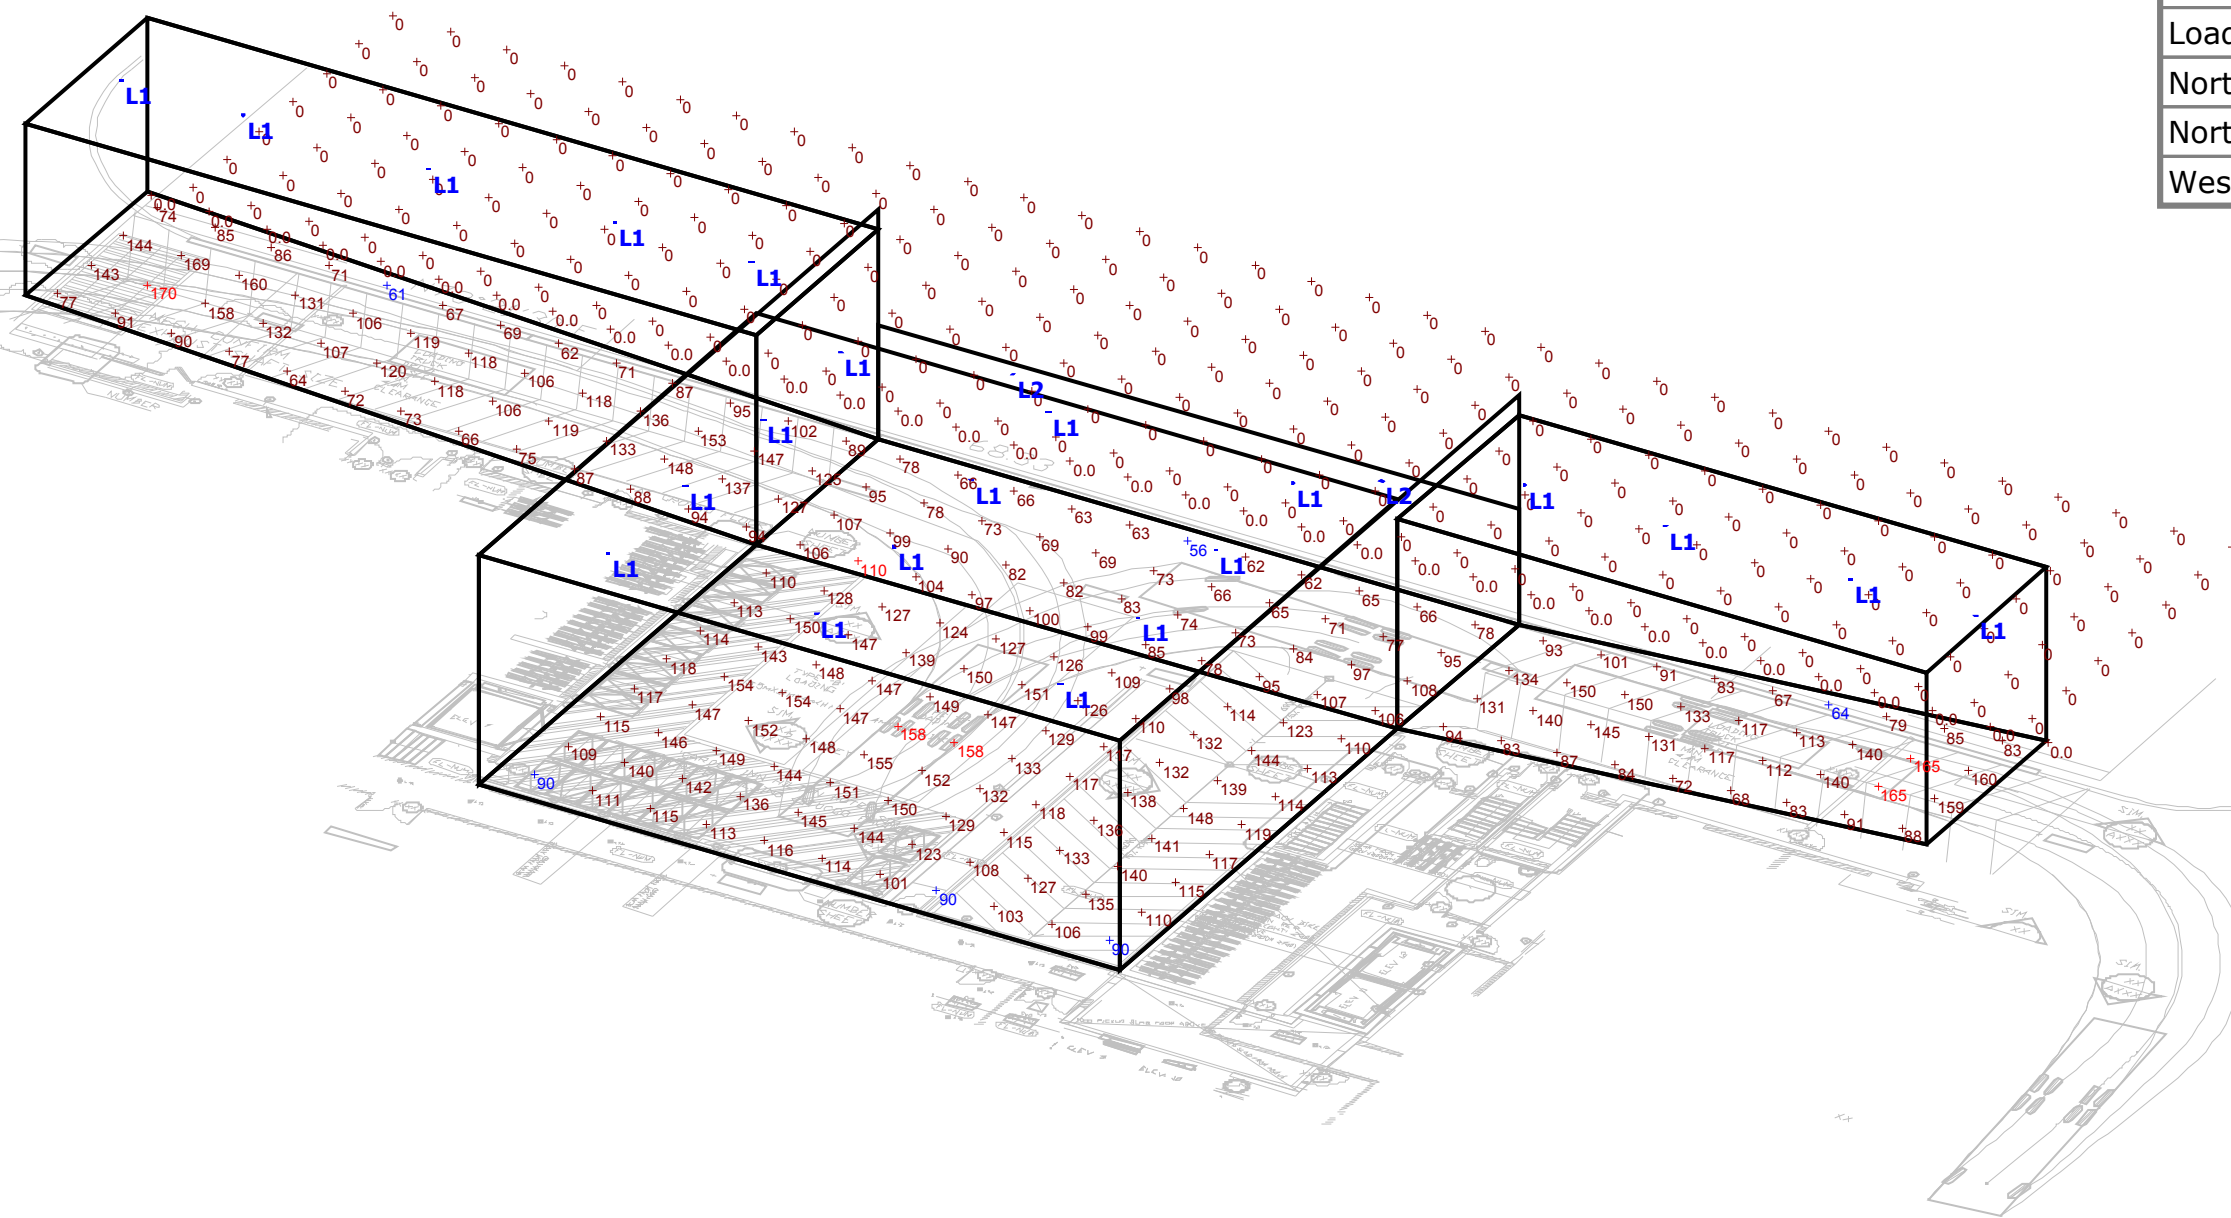

South East View

Luminaire Schedule									
Symbol	Label	QTY	Catalog Number	Description	Lamp	Number Lamps	Lumens per Lamp	LLF	Wattage
	L1	21	ICO-CYL 35/60 6AR 60 120	ICO-CYL DOWNLIGHT 3500K 6000 LUMENS 60 DEGREE BEAM	LED	1	6108.621	0.86	101.4
	L2	2	GLEON-AE-01-LED-E1-T2-7030	GALLEON LED AREA AND ROADWAY LUMINAIRE (1) 70 CRI, 3000K, 1A LIGHTSQUARE WITH 16 LEDS AND TYPE II OPTICS ABSOLUTE PHOTOMETRY IS BASED ON CALIBRATION FACTORS CREATED USING LAB LUMEN STANDARDS IN GONIOPHOTOMETER WITH TEST DISTANCE OF 28.75 FEET		16	4641.81	0.86	56

Statistics						
Description	Symbol	Avg	Max	Min	Max/Min	Avg/Min
Bottom of Ramp	+	82 lux	110 lux	56 lux	2.0:1	1.5:1
East Ramp	+	111 lux	165 lux	64 lux	2.6:1	1.7:1
Loading Dock	+	129 lux	158 lux	90 lux	1.8:1	1.4:1
North of Property Line	+	0 lux	0 lux	0 lux	N/A	N/A
North Property Line	+	0.0 lux	0.0 lux	0.0 lux	N/A	N/A
West Ramp	+	106 lux	170 lux	61 lux	2.8:1	1.7:1

Designer

Date

6/19/2015

Scale

Not to Scale

Drawing No.

Summary